
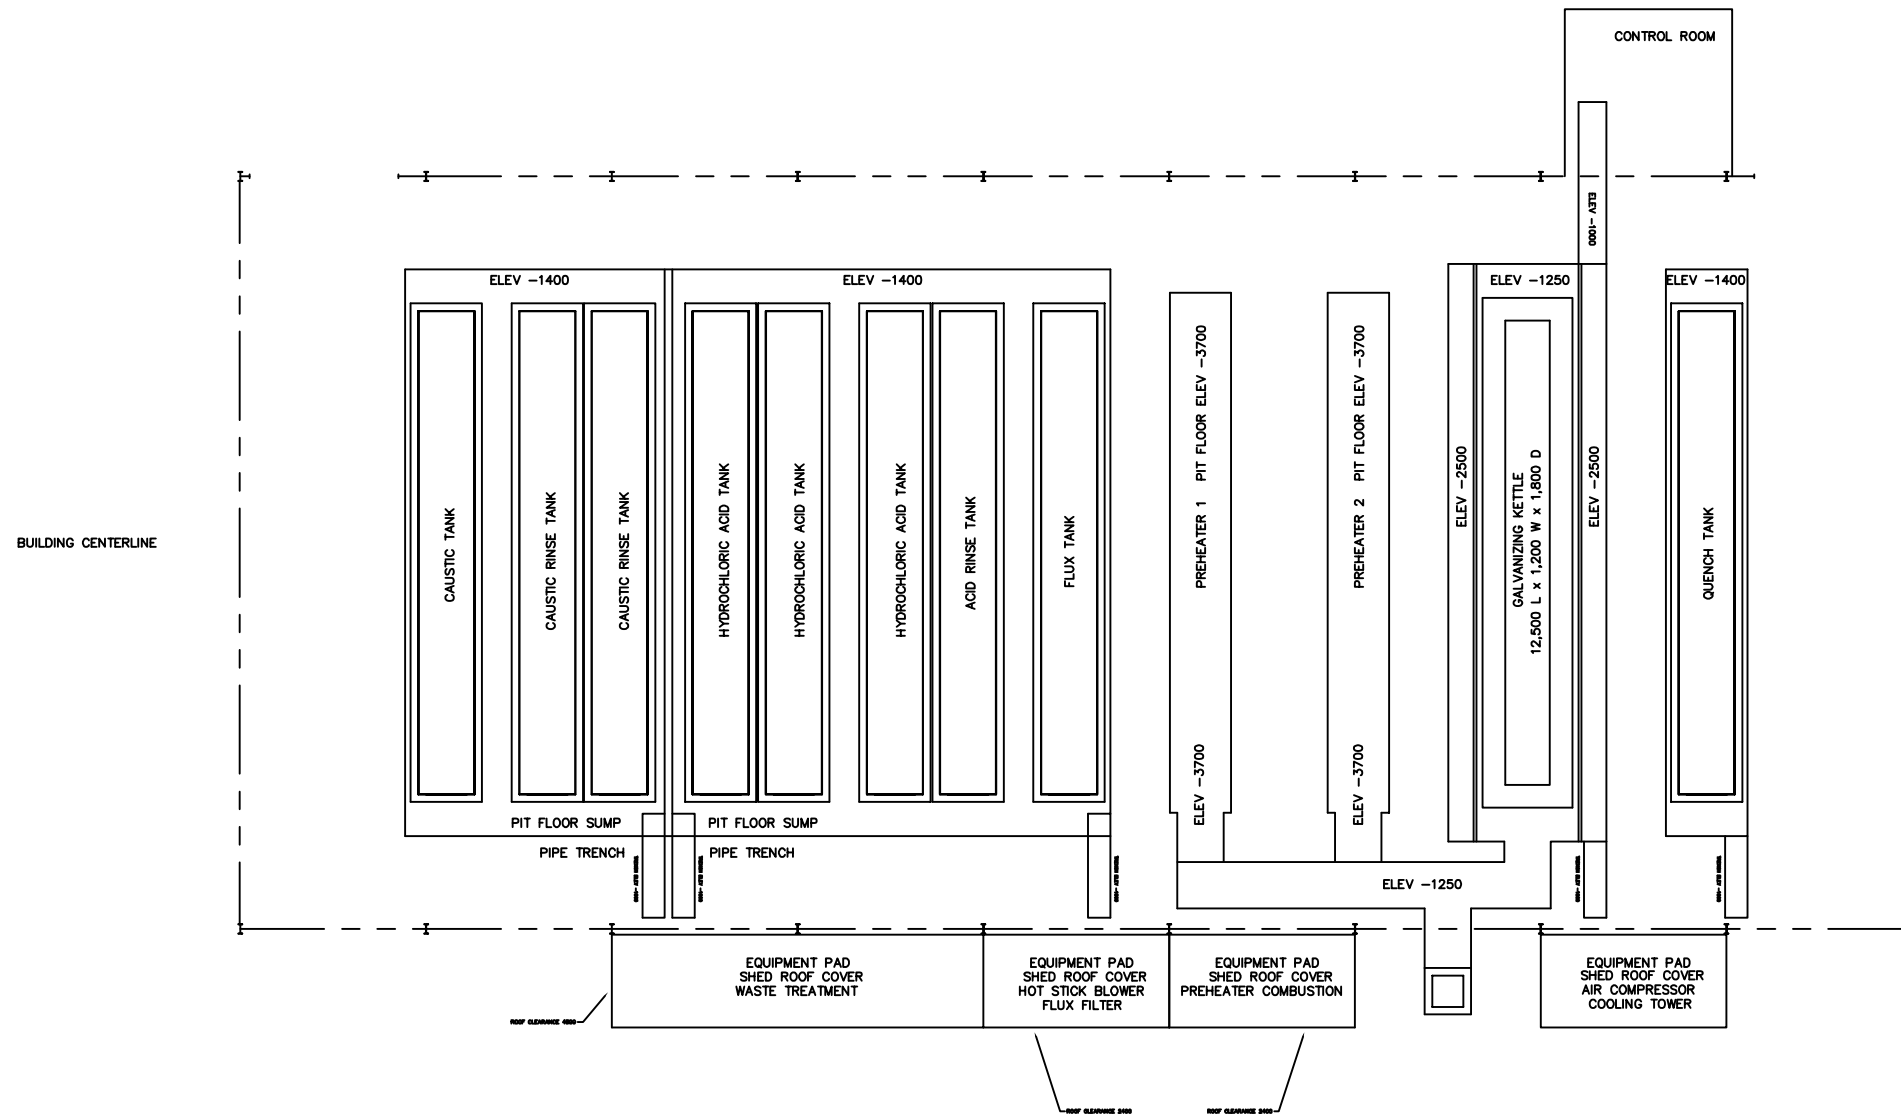


HOT DIP ZINC GALVANIZING PROCESS FLOW DIAGRAM

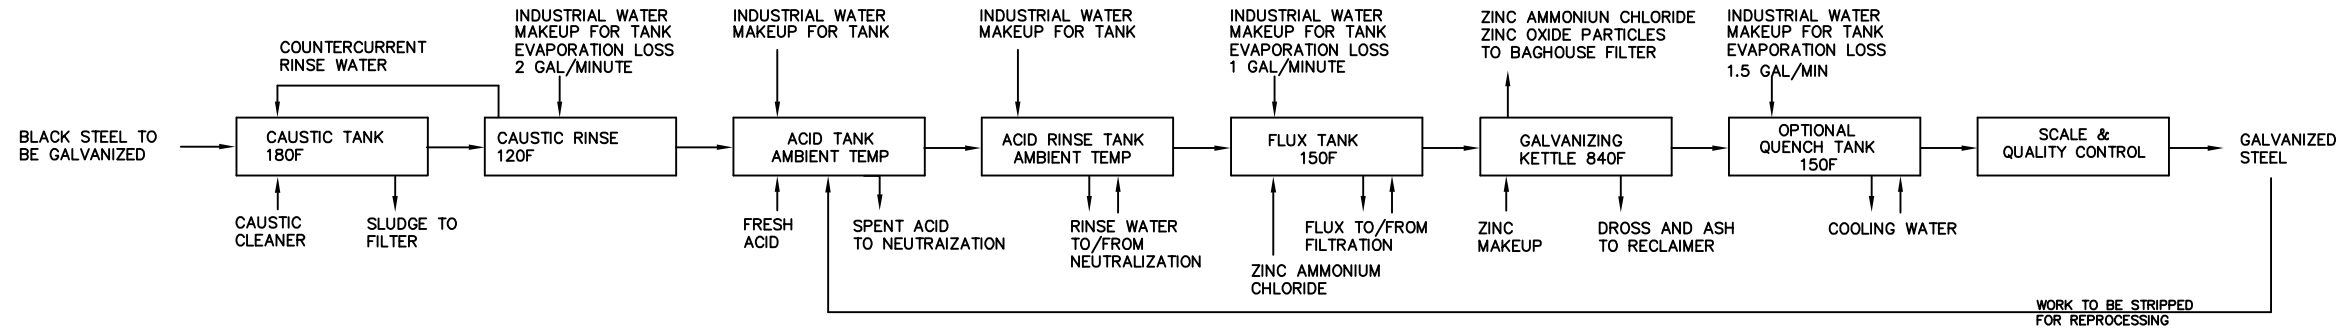

NO.	REVISION	DATE	BY

GTI ENGINEERING, INC.
 EQUIPMENT & ENGINEERING FOR
 THE GALVANIZING INDUSTRY
 TEXAS REGISTERED ENGINEERING FIRM F8067
 BOX 5486 KATY TX 77491 USA 281-398-0004
 SCALE: ANY
 DATE: 4 JUNE 2010
 TITLE: PERPENDICULAR PLANT LAYOUT
 TYPICAL
 DRAWING NO: GTPER42

THIS DRAWING IS THE PROPERTY OF GTI ENGINEERING, INC. AND IS CONSIDERED CONFIDENTIAL. IT MAY NOT BE REPRODUCED OR COPIED WITHOUT THE WRITTEN CONSENT OF GTI ENGINEERING, INC.